


# PROCESS FLOW DIAGRAM

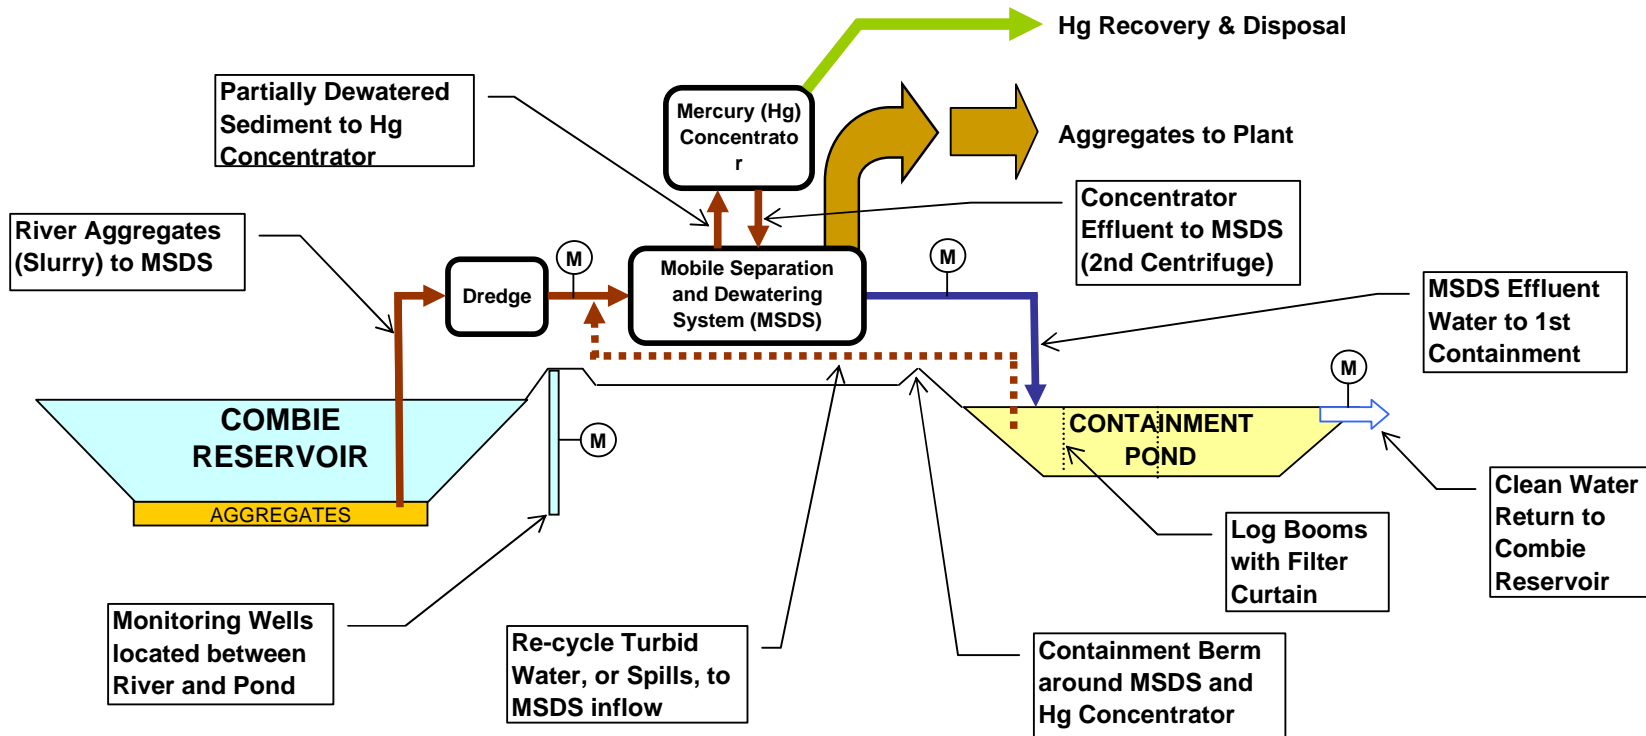

**M** ... WQ Monitoring Point

Job Title: <b>COMBIE RESERVOIR SEDIMENT AND MERCURY REMOVAL PROJECT</b>		
Date: June 2009	<i>NEVADA IRRIGATION DISTRICT</i> NEVADA COUNTY -- PLACER COUNTY GRASS VALLEY, CALIFORNIA	Scale: <u>None</u>
Drawn By: T. Crough		Sheet: <u>6</u> of <u>6</u>

**Figure 5**